
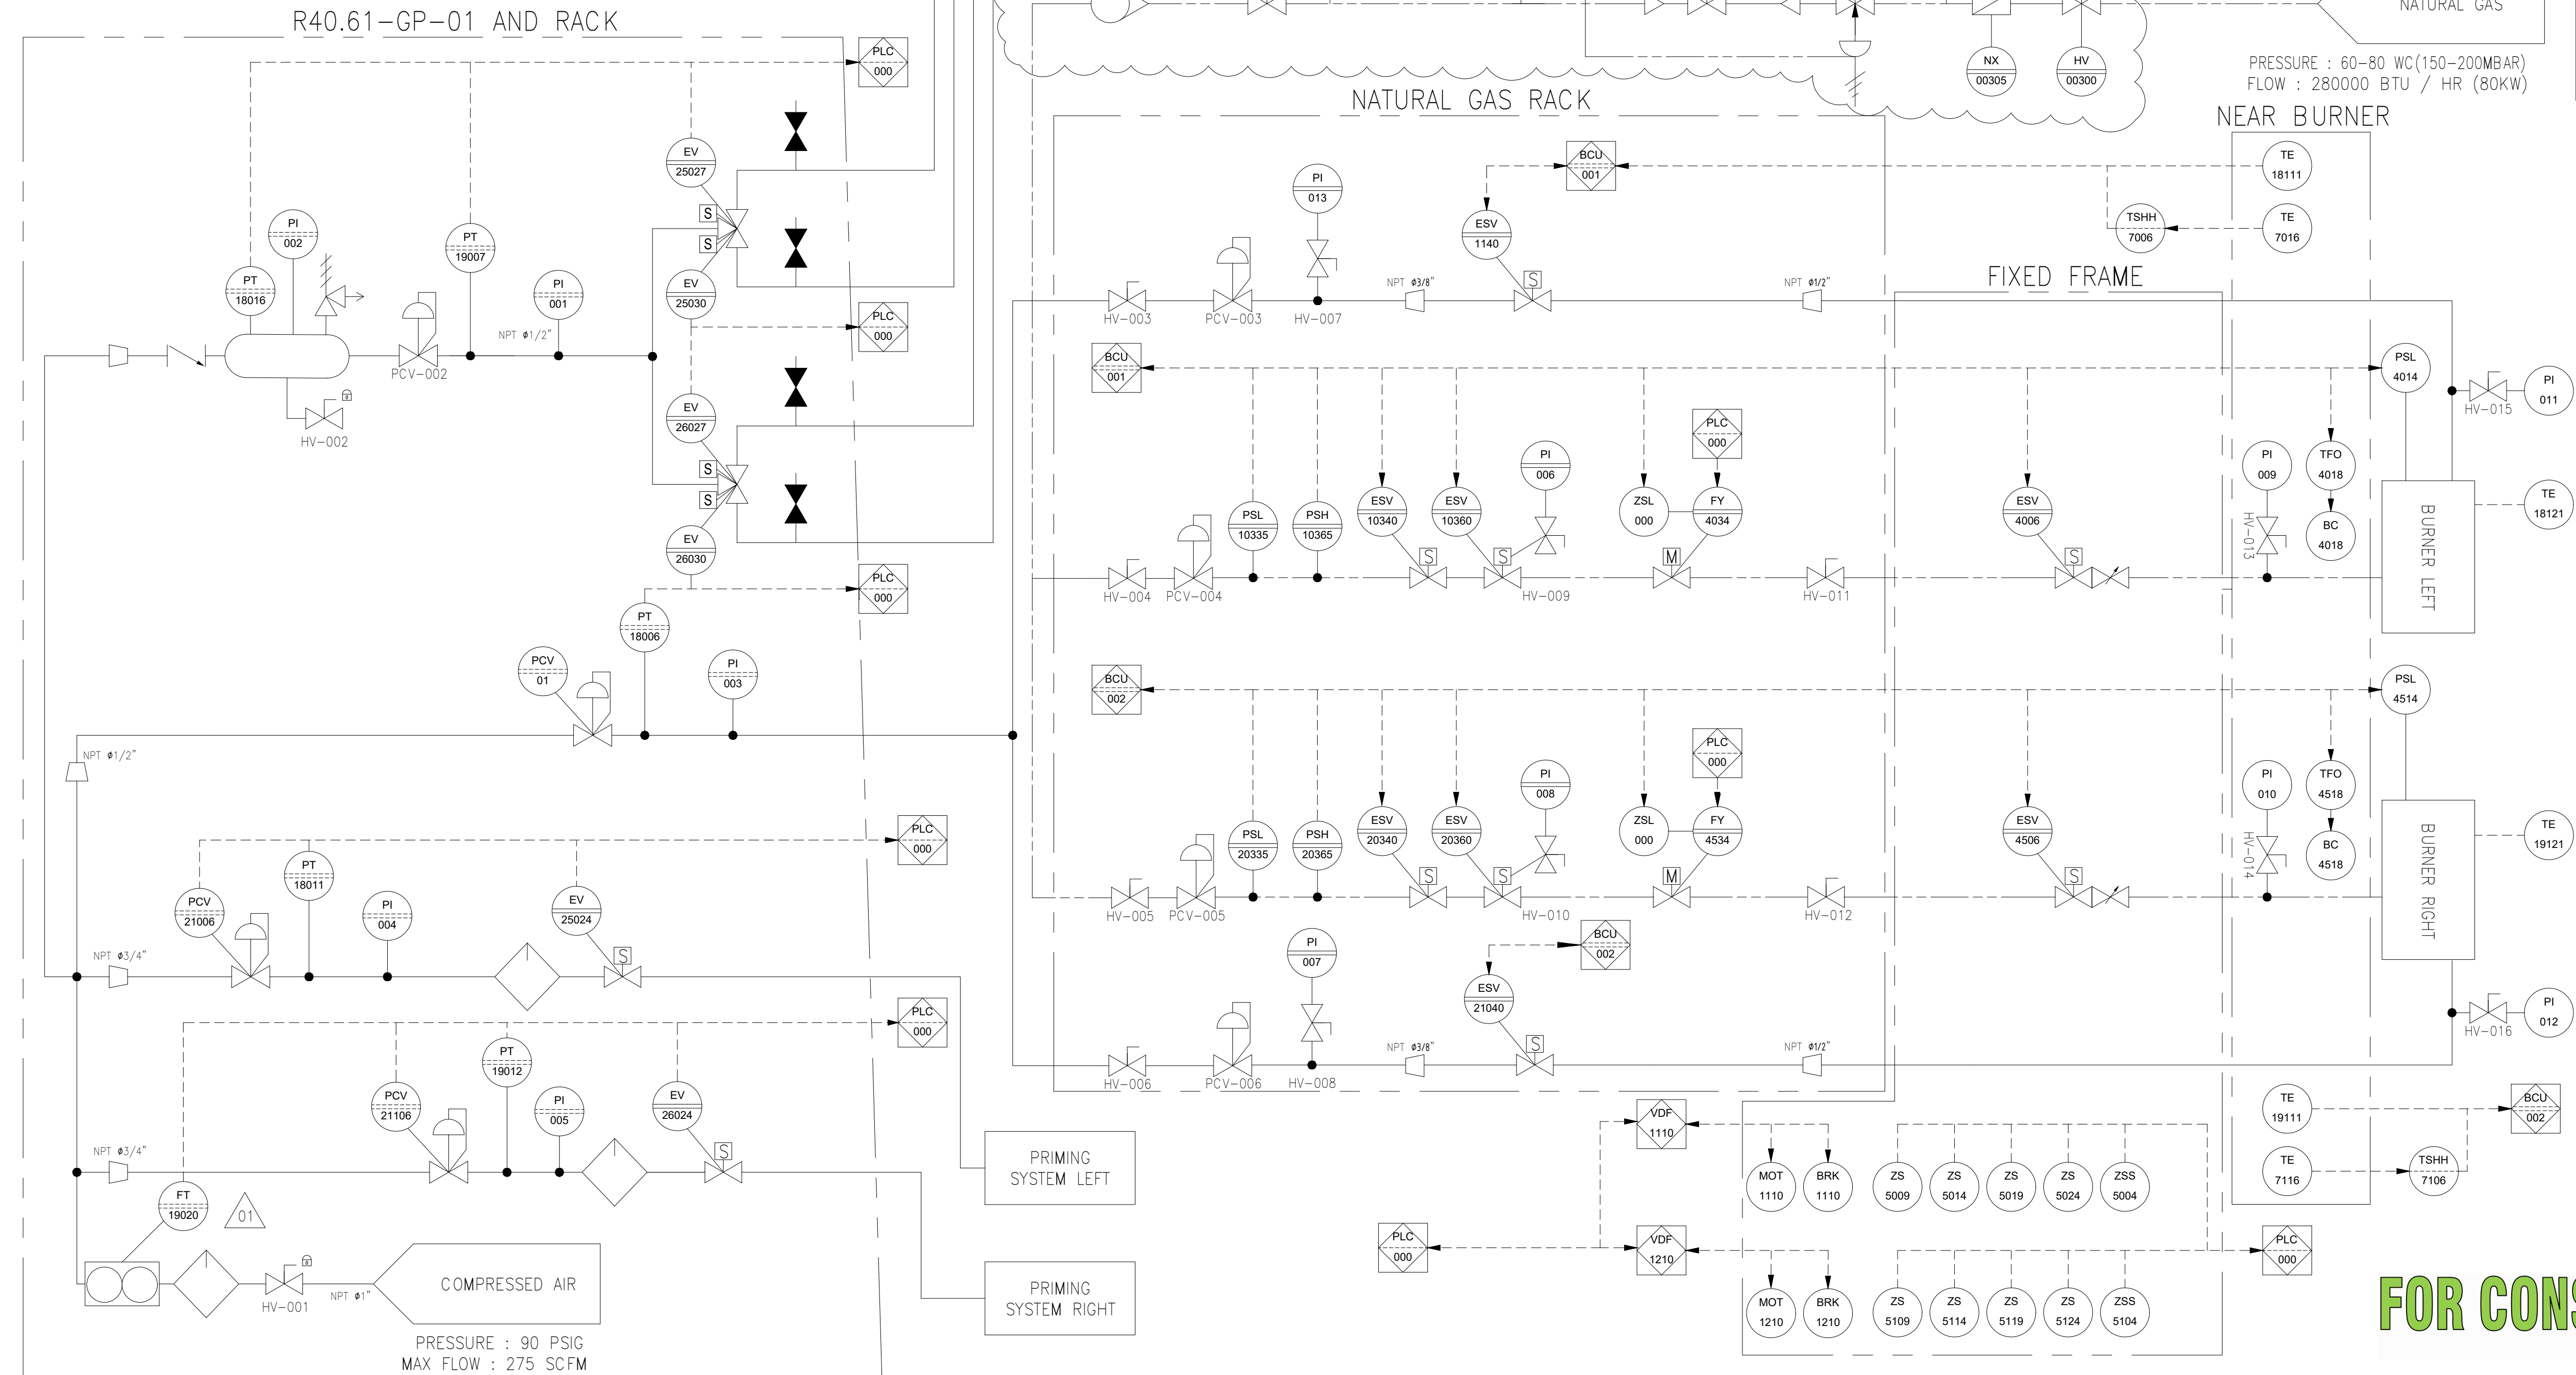
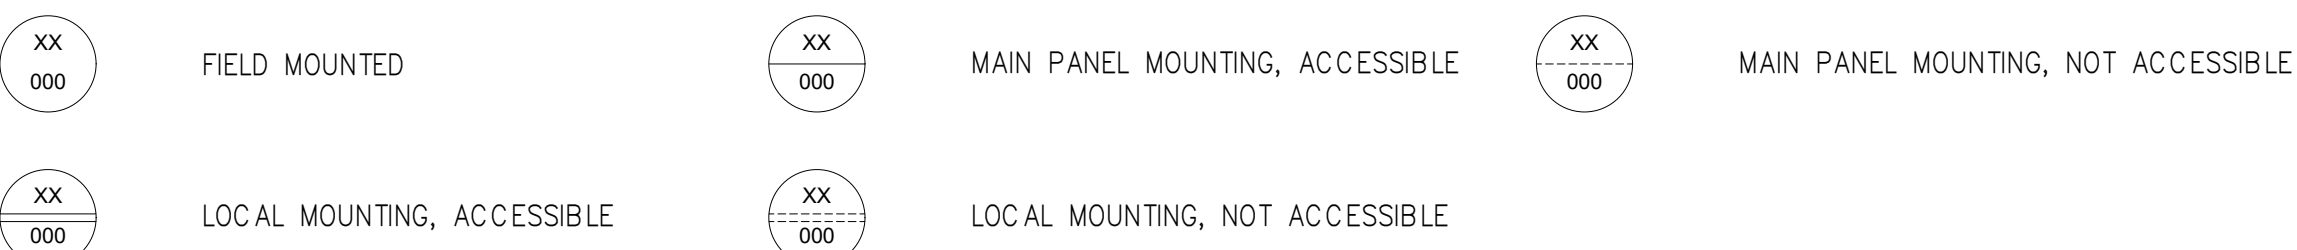


LEGEND

MOUNTING

DESCRIPTION

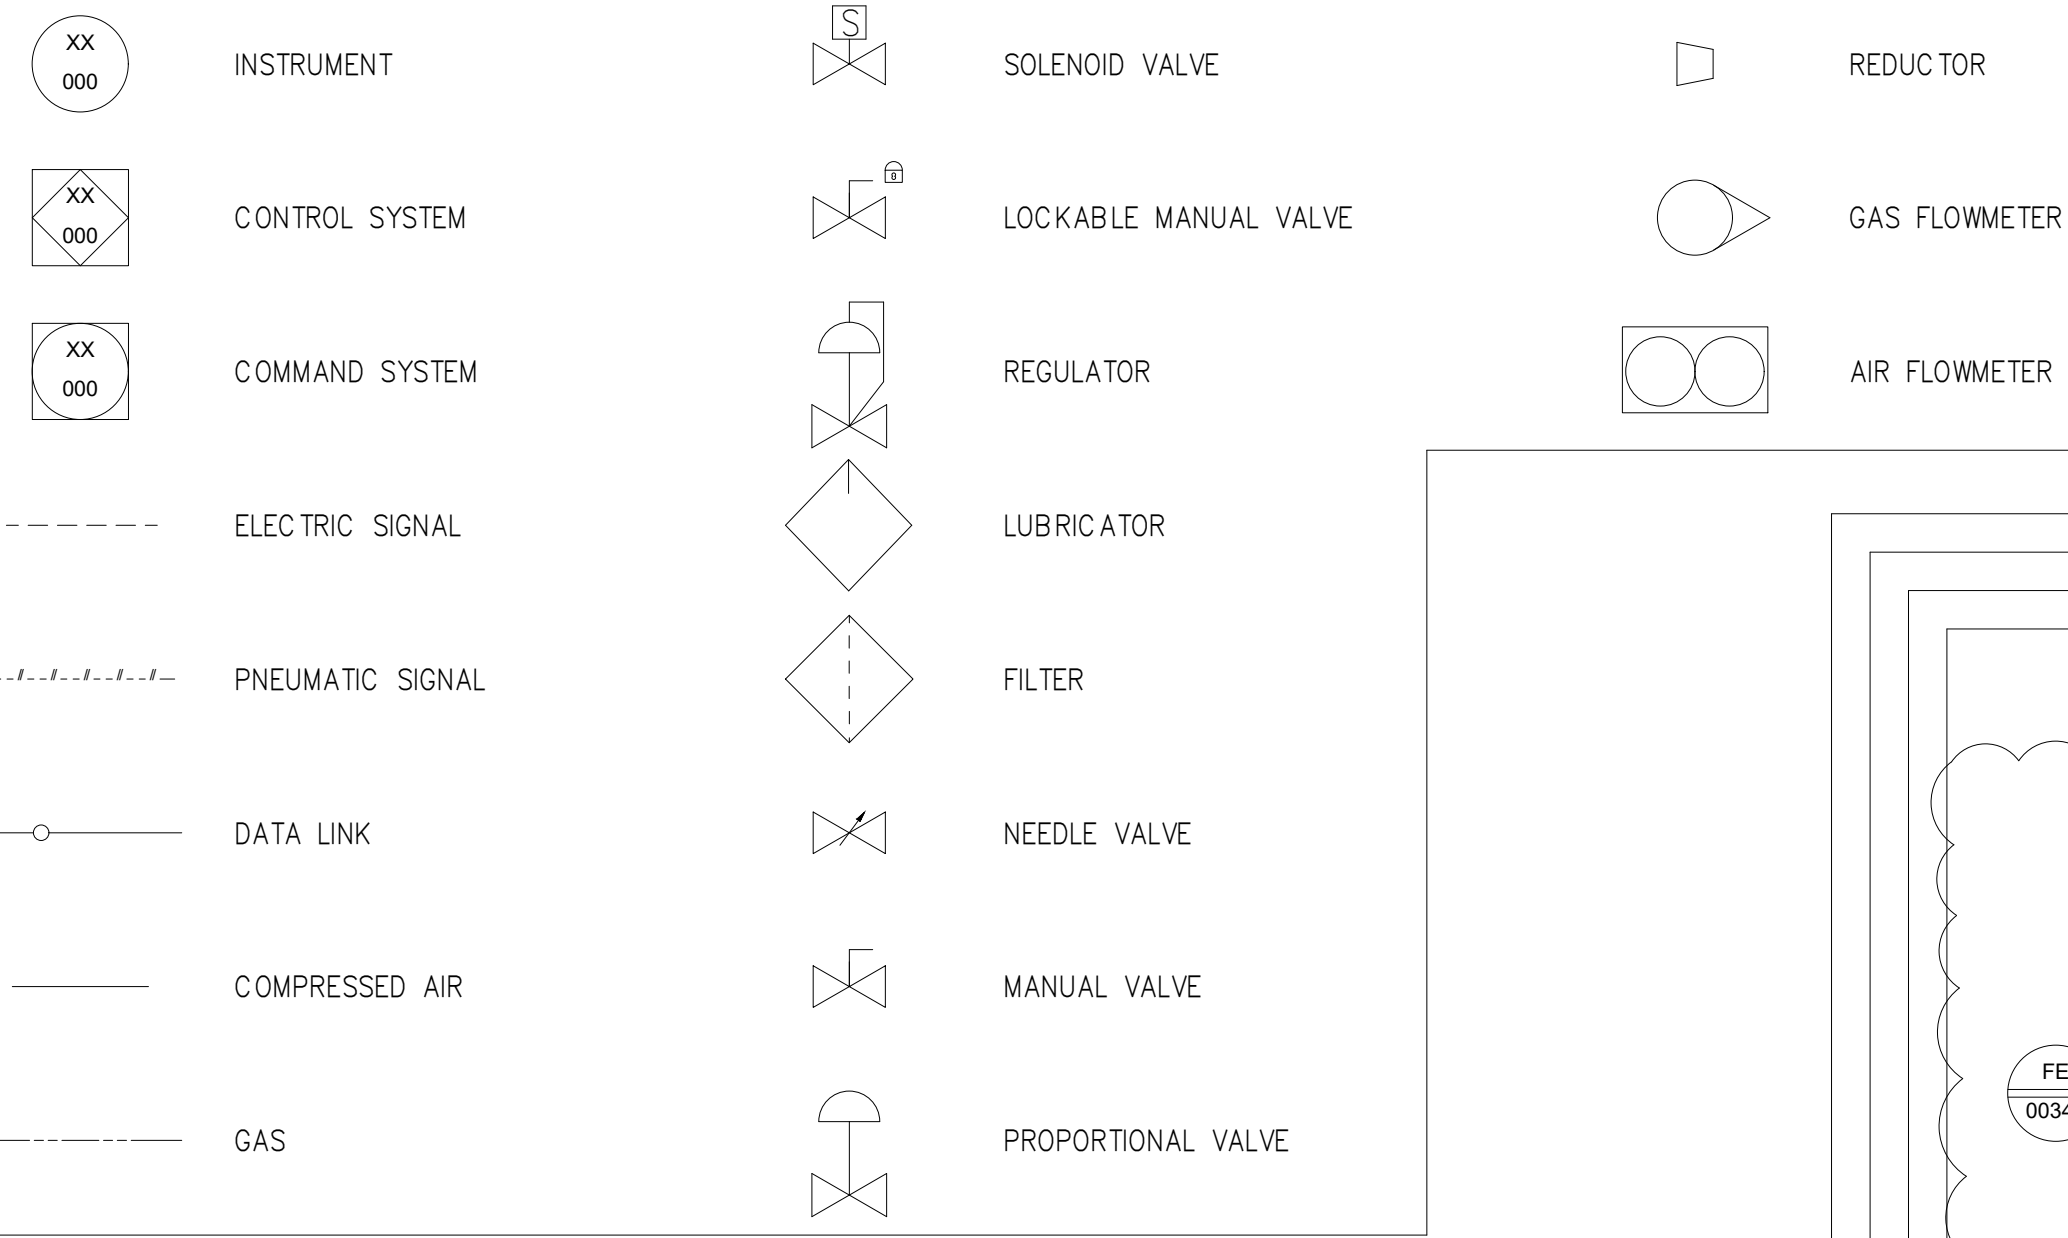

DESCRIPTION	
BC-4018	SPARK PIN AND FLAME DETECTOR BURNER LEFT
BC-4518	SPARK PIN AND FLAME DETECTOR BURNER RIGHT
BRK-1110	MOT-1110 MOTOR BRAKE DYNAPRIME LEFT
BRK-1210	MOT-1210 MOTOR BRAKE DYNAPRIME RIGHT
ESV-10340	SAFETY VALVE DYNAPRIME LEFT
ESV-10360	SAFETY VALVE DYNAPRIME LEFT
ESV-20340	SAFETY VALVE DYNAPRIME RIGHT
ESV-20360	SAFETY VALVE DYNAPRIME RIGHT
ESV-11040	COMPRESSED AIR SOLENOID VALVE DYNAPRIME LEFT
ESV-21040	COMPRESSED AIR SOLENOID VALVE DYNAPRIME RIGHT
ESV-4006	BURNER SOLENOID VALVE DYNAPRIME LEFT
ESV-4506	BURNER SOLENOID VALVE DYNAPRIME RIGHT
EV-25024	IMPACTOR ON/OFF VALVE DYNAPRIME LEFT
EV-25027	SOLENOIDE VALVE DRAINING PIN OPEN DYNAPRIME LEFT
EV-25030	SOLENOIDE VALVE DRAINING PIN CLOSE DYNAPRIME LEFT
EV-26024	IMPACTOR ON/OFF VALVE DYNAPRIME RIGHT
EV-26027	SOLENOIDE VALVE DRAINING PIN OPEN DYNAPRIME RIGHT
EV-26030	SOLENOIDE VALVE DRAINING PIN CLOSE DYNAPRIME RIGHT
FY-4034	BURNER PROPORTIONNAL VALVE DYNAPRIME LEFT
FY-4534	BURNER PROPORTIONNAL VALVE DYNAPRIME RIGHT
MOT-1110	ACTUATOR FOR COVER DYNAPRIME LEFT
MOT-1210	ACTUATOR FOR COVER DYNAPRIME RIGHT
HV-001/002	LOCKABLE MANUAL VALVE
HV-002 TO 016	MANUAL VALVE
PCV-21006	PROP. VALVE WITH FEEDBACK AIR IMPACTOR
PCV-21106	PROP. VALVE WITH FEEDBACK AIR IMPACTOR
PCV-01	PROPORTIONAL VALVE AIR INTAKE
PCV-002 TO 006	PRESSURE REGULATOR
PI-01 TO 13	PRESSURE INDICATOR
PSH-10365	HIGH PRESSURE SWITCH BURNER DYNAPRIME LEFT
PSH-20365	HIGH PRESSURE SWITCH BURNER DYNAPRIME RIGHT
PSL-10335	LOW PRESSURE SWITCH BURNER DYNAPRIME LEFT
PSL-20335	LOW PRESSURE SWITCH BURNER DYNAPRIME RIGHT
PSL-4014	LOW AIR PRESSURE BURNER DYNAPRIME LEFT
PSL-4514	LOW AIR PRESSURE BURNER DYNAPRIME RIGHT
PT-18006	PRESSURE TRANSMITTER GAS VENTURI DYNAPRIME
PT-19007	PRESSURE TRANSMITTER GAS VENTURI DRAIN PIN
PT-18011	PRESSURE TRANSMITTER IMPACTOR DYNAPRIME LEFT
PT-19012	PRESSURE TRANSMITTER IMPACTOR DYNAPRIME RIGHT
PT-18016	PRESSURE TRANSMITTER CONTINGENCY AIR SUPPLY
TFO-4018	TRANSFORMATOR SPARK BURNER DYNAPRIME LEFT
TFO-4518	TRANSFORMATOR SPARK BURNER DYNAPRIME RIGHT
TE-18111	THERMOCOUPLE CONTROL BURNER DYNAPRIME LEFT
TE-19111	THERMOCOUPLE CONTROL BURNER DYNAPRIME RIGHT
TE-7016	THERMOCOUPLE HIGH LIMIT DYNAPRIME LEFT
TE-7116	THERMOCOUPLE HIGH LIMIT DYNAPRIME RIGHT
TE-18121	THERMOCOUPLE FLAME TEMPERATURE DYNAPRIME LEFT
TE-19121	THERMOCOUPLE FLAME TEMPERATURE DYNAPRIME RIGHT
TSHH-7006	HIGH TEMPERATURE MONITOR DYNAPRIME LEFT
TSHH-7106	HIGH TEMPERATURE MONITOR DYNAPRIME RIGHT
ZS-5009/5104	PROXIMITY SWITCH COVER OPEN POSITION
ZS-5014/5114	PROXIMITY SWITCH COVER OVERTRAVEL POSITION
ZS-5019/5119	PROXIMITY SWITCH COVER LOCK LOCKED POSITION
ZS-5024/5124	PROXIMITY SWITCH COVER LOCK UNLOCKED POSITION
ZSS-5004/5104	SAFETY SWITCH CLOSED COVER FOR BURNER START
HV-00300	RUB - BALL VALVE S95, 1.0" NPT
NE-00305	HKS - GAS FILTER, 1.0" NPT
PI-00310	PITANCO - PRESSURE GAUGE, 0-15 PSIG
HV-00310	RUB - BALL VALVE S95, 0.25" NPT
SLM-00315	HKS - SLAMSHUT VALVE, 1" NPT, 200-350MBAR SPRING.
PCV-00320	HKS - PRESSURE REGULATOR, 0.5" NPT, 150-230 MBAR
PRV-00325	HKS - OVERPRESSURE RELIEF VALVE, 165-330 MBAR
PI-00330	PITANCO - PRESSURE GAUGE, 0-100"WC
HV-00330	RUB - BALL VALVE S95, 0.25" NPT
HV-00335	RUB - BALL VALVE S95, 1.0" NPT
FE-00340	ELSTER - DIAPHRAGM GAS COUNTER

FOR CONSTRUCTION

REV.	DESCRIPTION	DATE	BY	APPR.	OIQ NUM.
02	GAS FLOWMETER ADDEED	2025-07-25	JNB	SLJ	5074693
01	AIR SUPPLY FLOWMETER # ADDED	2025-07-07	JNB	SLJ	5074693
00	FOR CONSTRUCTION	2025-06-27	FNP	SLJ	5074693
REVISIONS					

CONFIDENTIALITE

THE PRESENT DOCUMENT AND ALL RELATED INFORMATION ARE THE PROPERTY OF DYNAMIC CONCEPT OR IS MADE AVAILABLE EXPRESSLY SUBJECT TO NONDISCLOSURE AND RESTRICTIVE USAGE AGREEMENTS. THEY SHALL BE KEPT CONFIDENTIAL AND CAN NOT BE USED OR REPRODUCED IN ANY MANNER WITHOUT THE WRITTEN CONSENT OF DYNAMIC CONCEPT. THIS DOCUMENT SHALL BE RETURNED UPON REQUEST.

ENGINEER BY: SARAH JEAN

VERIFIED BY: SARAH JEAN

DATE: 2025-05-09

ENGINEER BY: SARAH JEAN

VERIFIED BY: SARAH JEAN

DATE: 2025-05-09

DYNAMIC CONCEPT

Saguenay (QC)

Canada

418.542.6164

WWW.DYNAMIC-CONCEPT.CA

PREVIOUS DRAWING: 901-001

NEXT DRAWING: 903-003

GAS SUPPLIED DYNAPRIME

P&ID

PNEUMATIC DIAGRAM

DRAWING NO: 24121-905-005

REVISION 02

FORMAT A1